



TYPICAL WATER SERVICE DETAIL
N.T.S.

NOTE:
METER PIT AND CURB BOX MUST BE INSTALLED BETWEEN THE STREET AND THE R.O.W. LINE
METER SHALL BE INSTALLED 18" BELOW FINISHED GRADE (OR AS REQUIRED BY UTILITY PROVIDER)
CONTRACTOR IS RESPONSIBLE FOR COORDINATION WITH UTILITY PROVIDER.
ALL MATERIAL AND CONNECTION SPECS SHALL BE PERFORMED IN ACCORDANCE WITH UTILITY PROVIDER'S REQUIREMENTS.

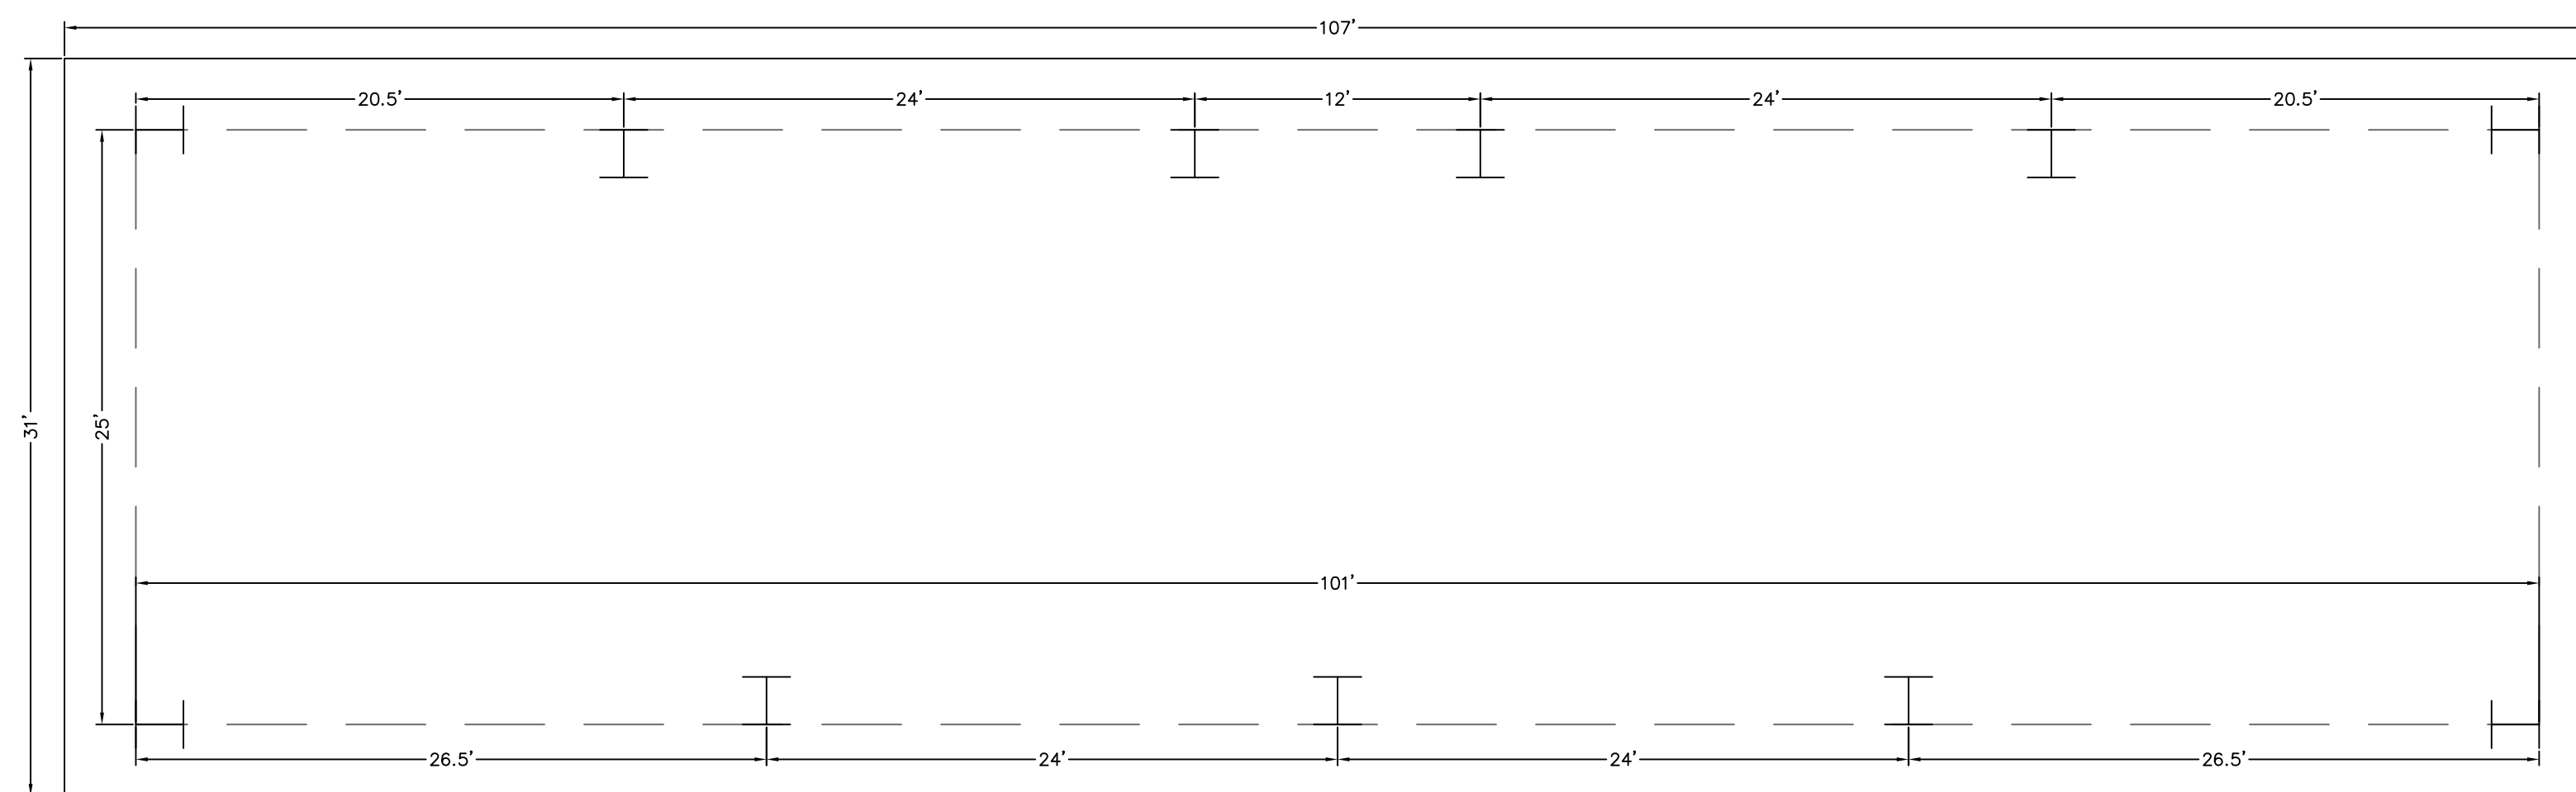


CANOPY PLAN VIEW AND POST SPACING DETAIL
NOT TO SCALE

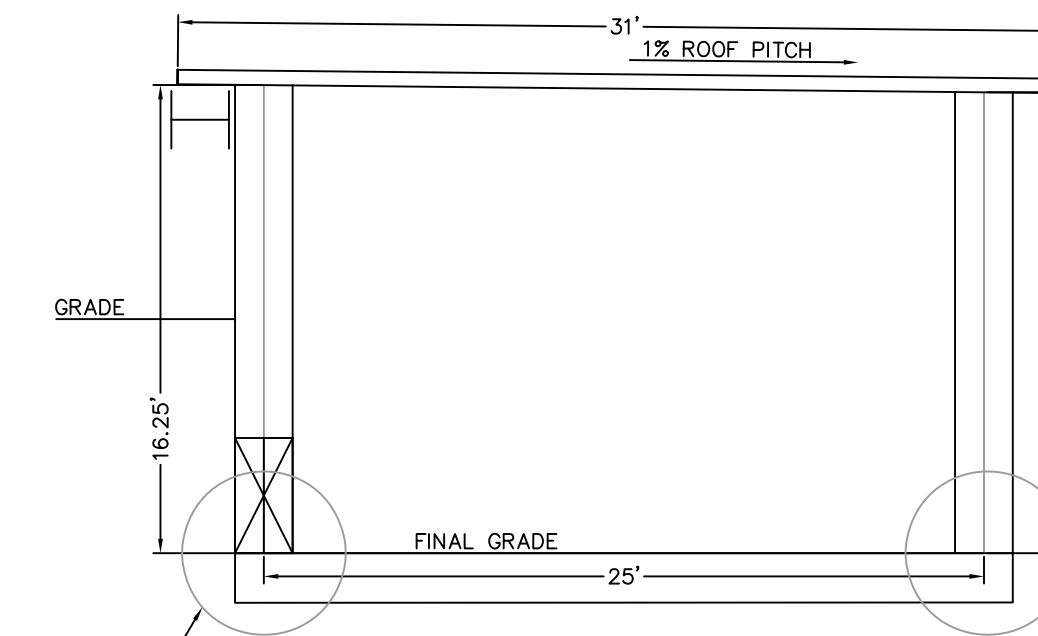

CANOPY STRUCTURAL FRAMING DETAIL
NOT TO SCALE


Arm Mount - Direct to Pole

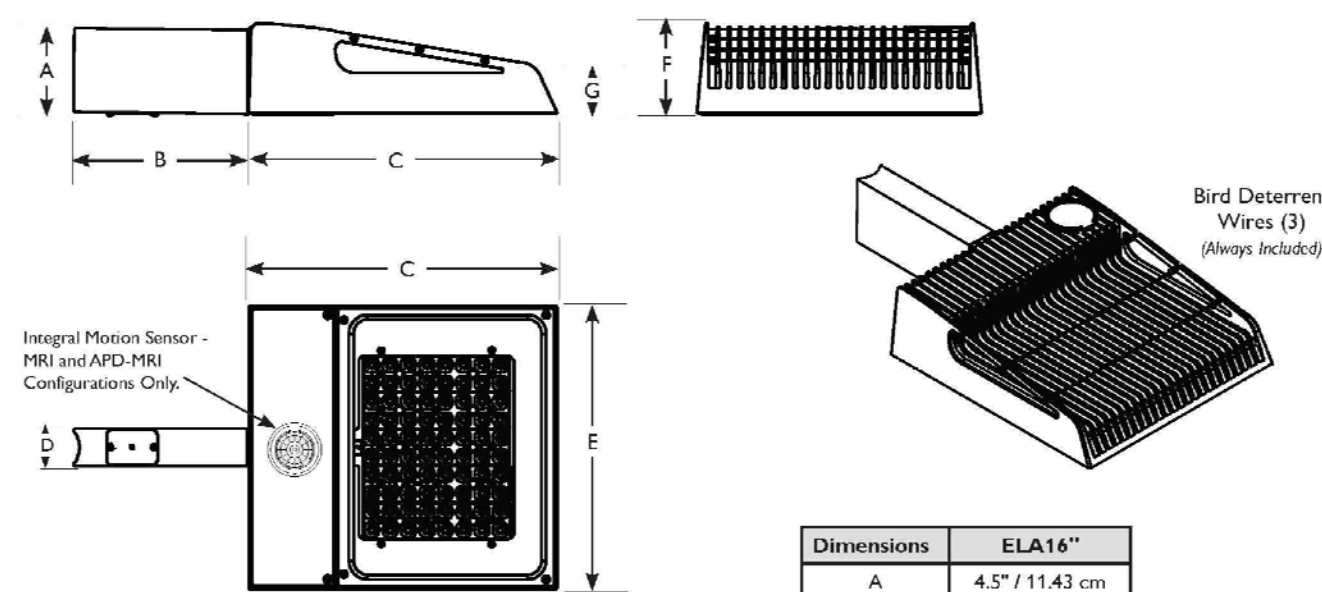



| Dimensions | ELA16" |
|------------|------------------|
| A | 4.57 / 11.43 cm |
| B | 6.20 / 15.95 cm |
| C | 16.53 / 41.99 cm |
| D | 2" / 5.08 cm |
| E | 15.27 / 38.61 cm |
| F | 4.67 / 11.68 cm |
| G | 1.53 / 3.89 cm |

| Effective Projected Area (EPA) | Approximate Weight - Single Luminaire | | |
|--------------------------------|---------------------------------------|------------|------------|
| | Single | Twin | 3/4 |
| ELA16" | .87 sq ft | 1.74 sq ft | 2.49 sq ft |
| | .081 sq m | .162 sq m | .232 sq m |

LUMINAIRE DETAIL

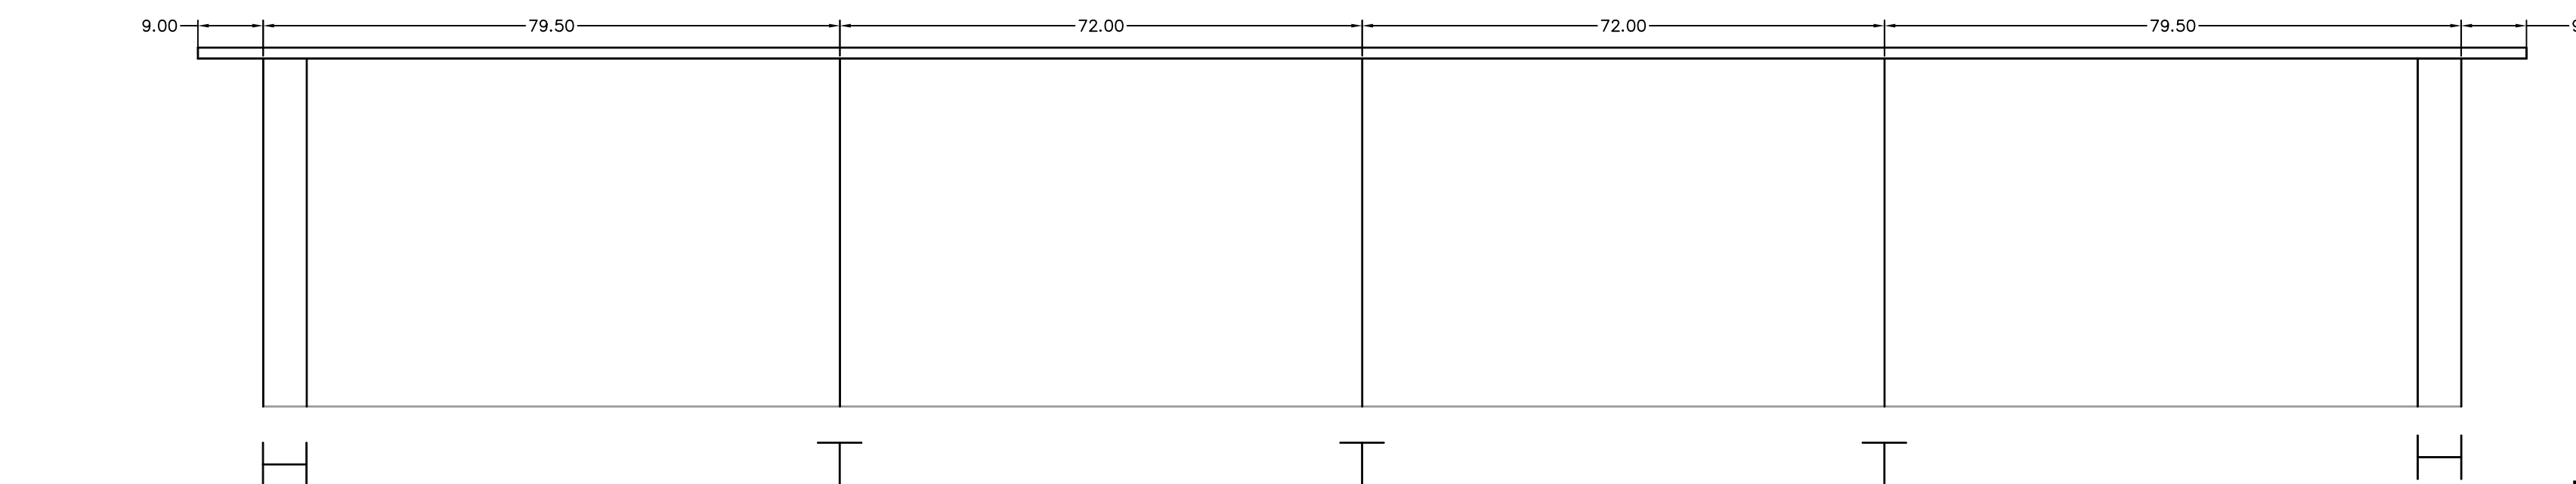


CANOPY CROSS-SECTION DETAIL
NOT TO SCALE

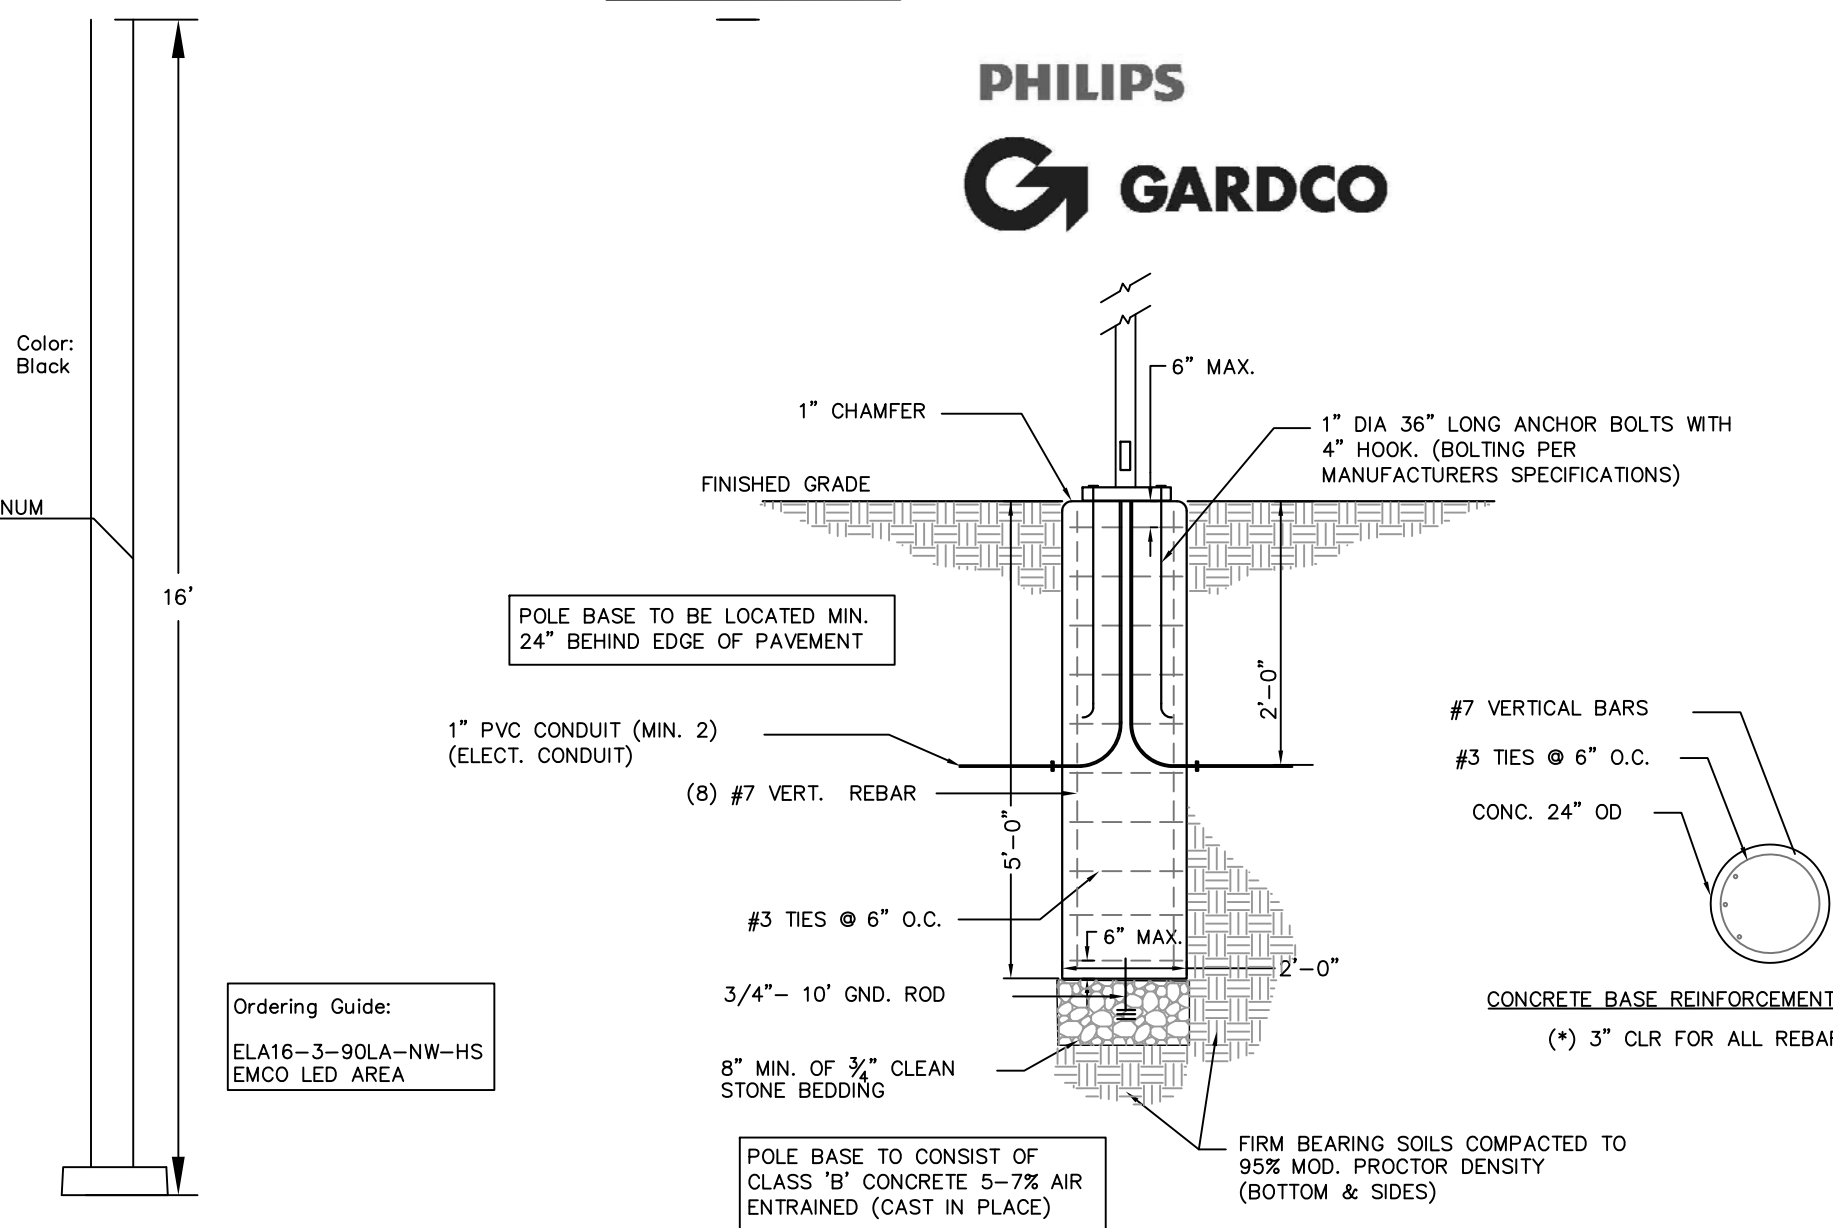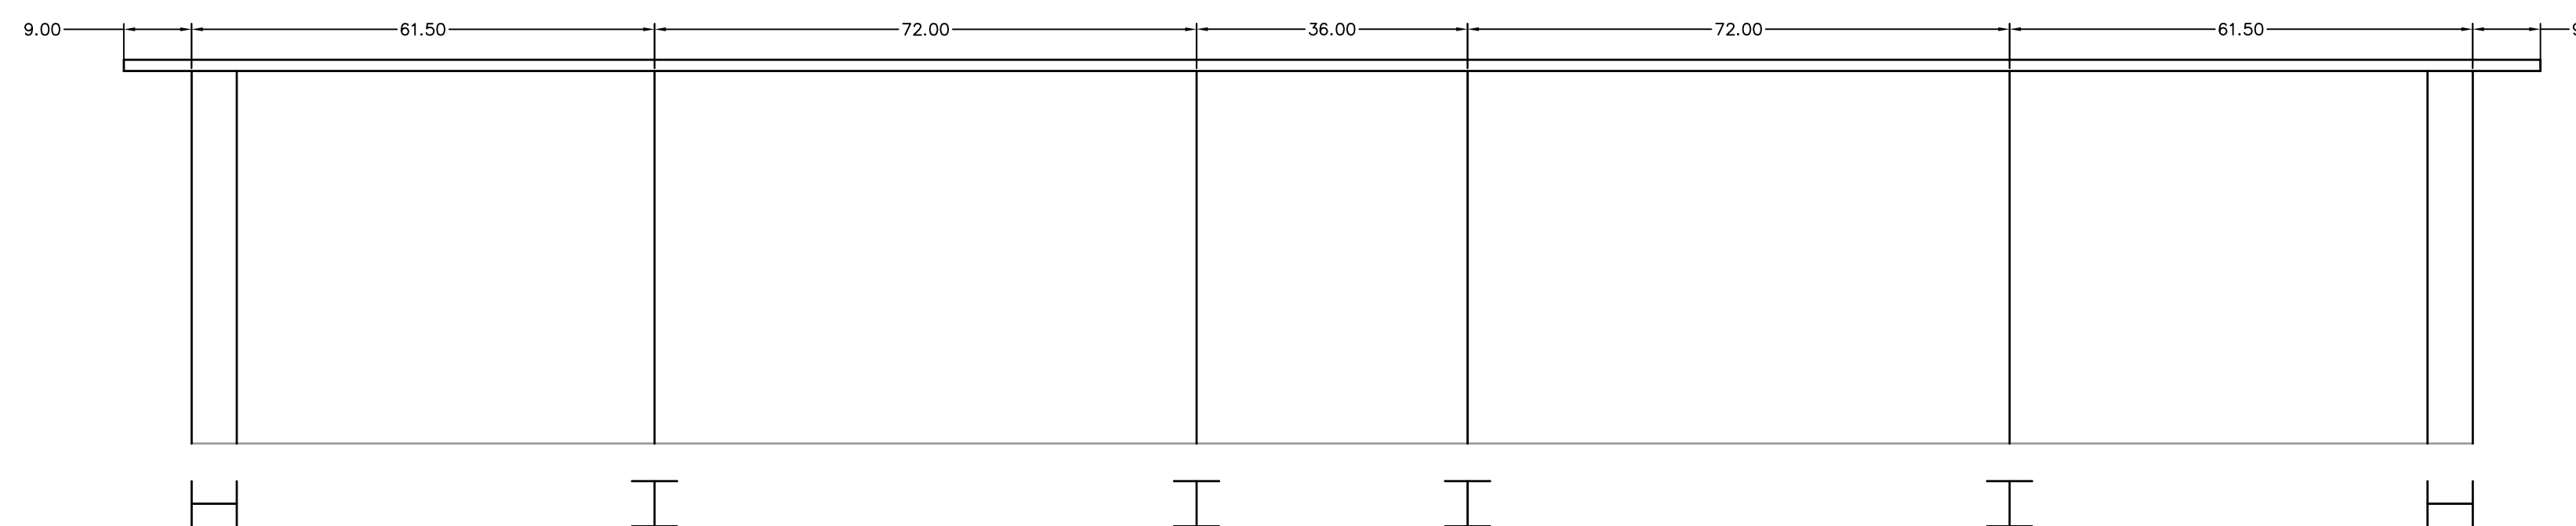


TYPICAL PARKING LOT LIGHT FIXTURE/POLE BASE DETAIL
N.T.S.

SINGLE LANTERN LIGHT DETAIL
NOT TO SCALE

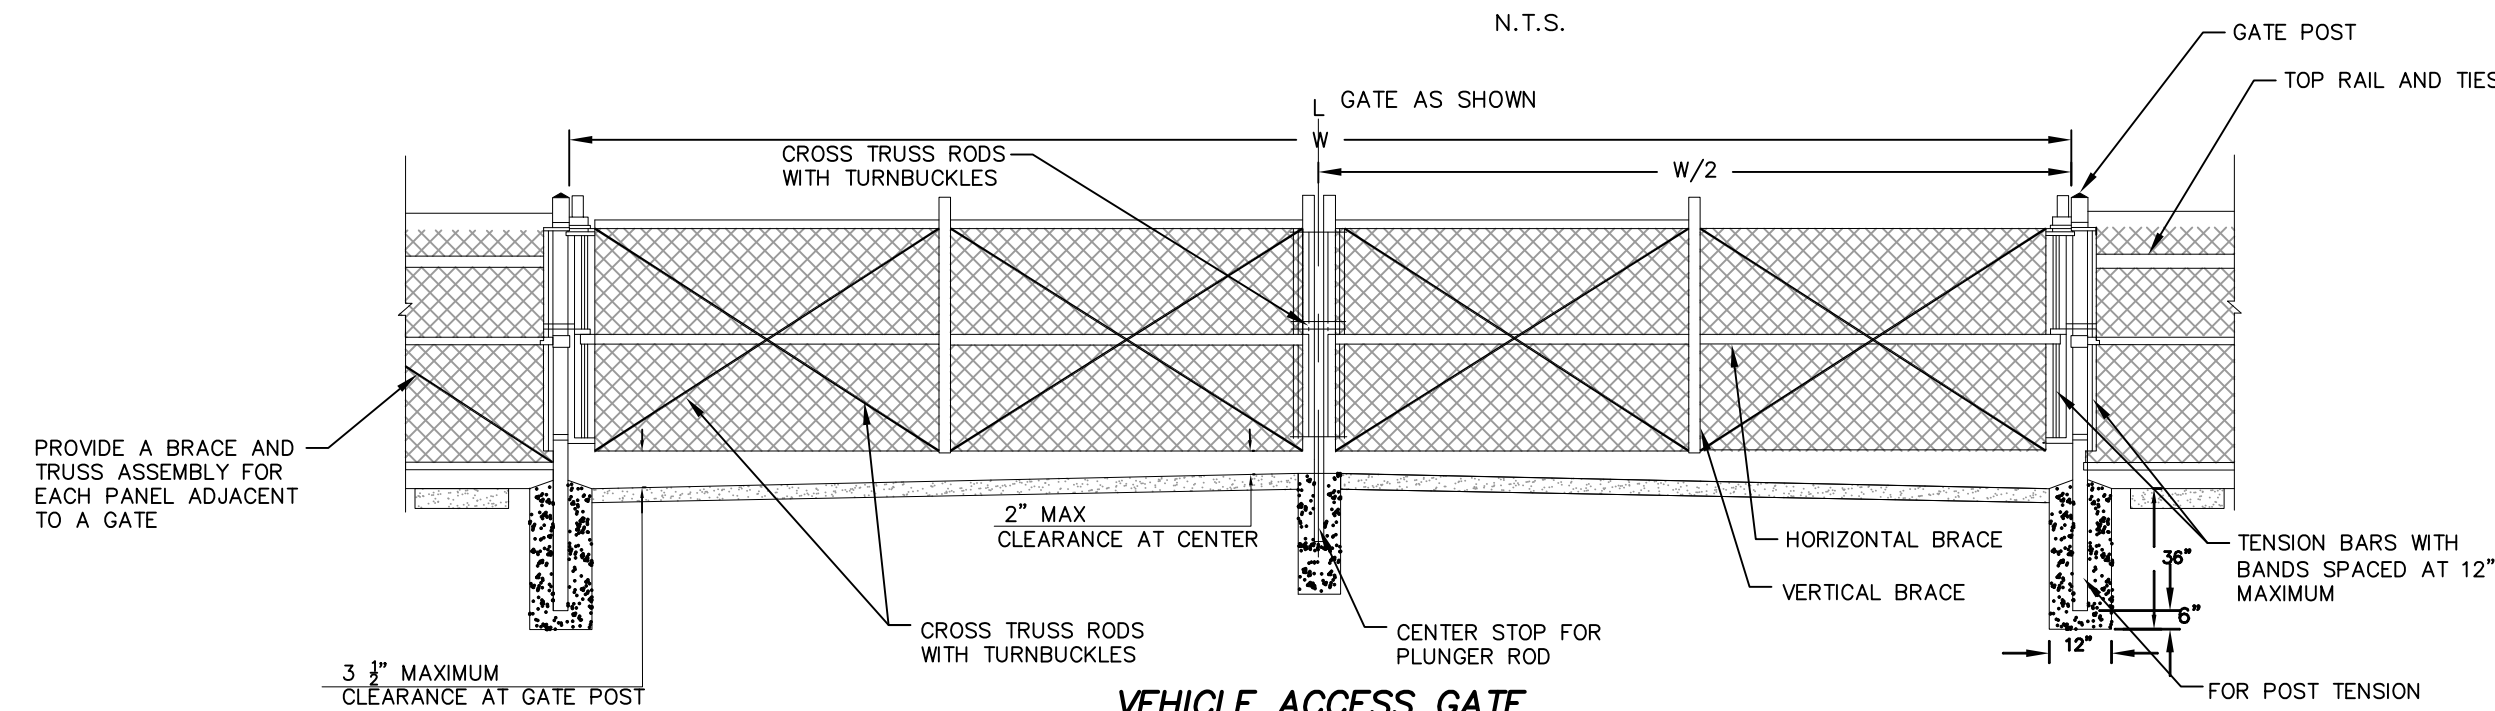


VEHICLE ACCESS GATE
NOT TO SCALE

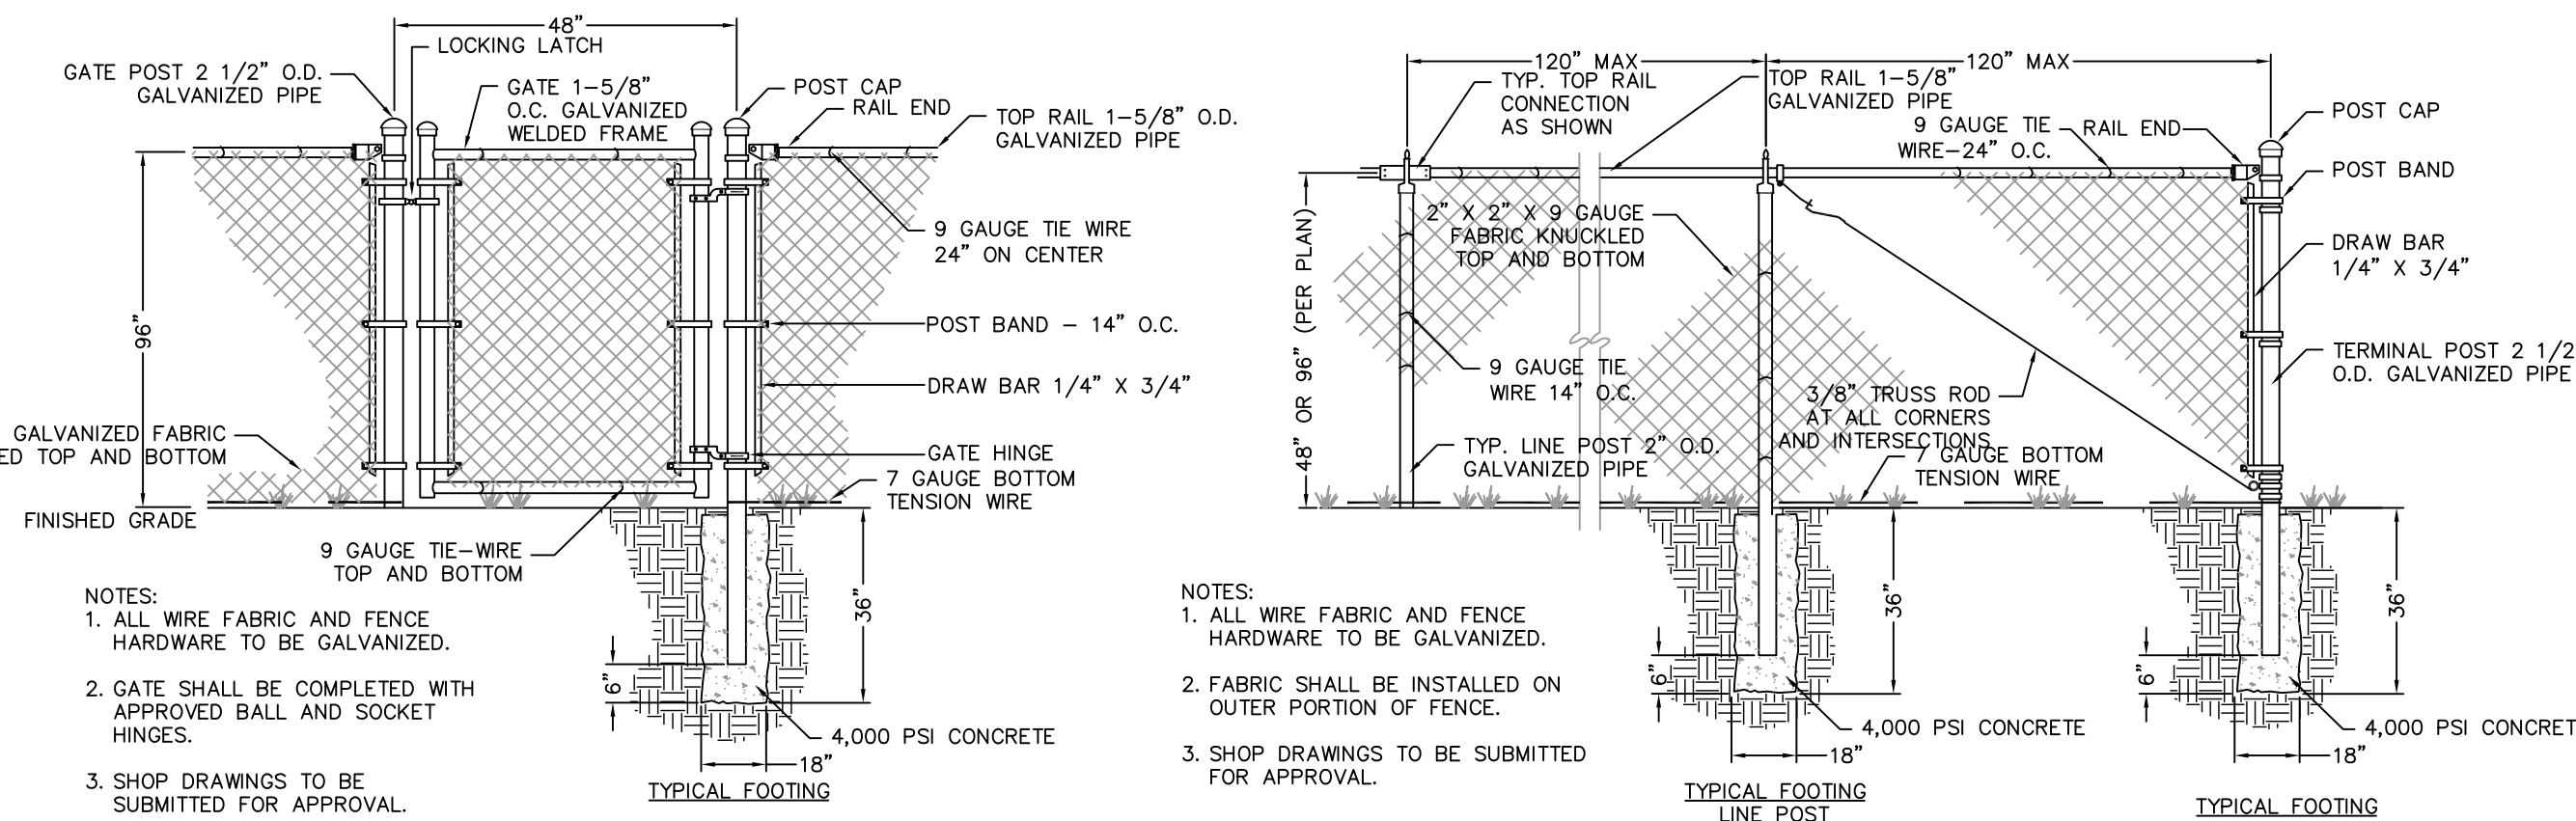

CHAIN LINK FENCE DETAIL
NOT TO SCALE

- NOTES:**
- CANOPY STRUCTURAL LAYOUT TO BE DESIGNED BY OTHERS.
 - FINAL STRUCTURAL DESIGN DRAWINGS TO BE SUBMITTED FOR REVIEW AS PART OF CONSTRUCTION PERMIT PROCESS.
 - DETAILS ARE PROVIDED FOR DIMENSIONAL PURPOSES AND DO NOT REPRESENT FINAL CONSTRUCTION DRAWINGS. CONTRACTOR TO SUBMIT SHOP DRAWINGS FOR REVIEW AND APPROVAL BY DESIGN ENGINEER, BOROUGH ENGINEER, AND BUILDING DEPARTMENT.

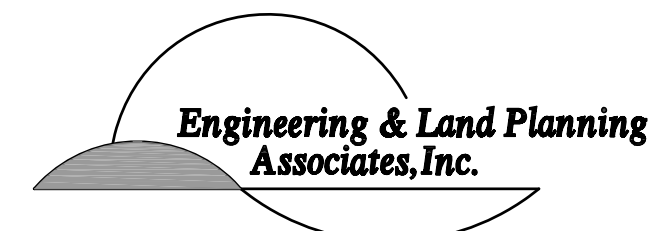

140 WEST MAIN STREET HIGH BRIDGE, NJ 08829
PH. 908-238-0544 FAX. 908-238-9572
A PROFESSIONAL ASSOCIATION
CERTIFICATE OF AUTHORIZATION NO.: 24GA28021500

| NO. | REVISION | BY | DATE |
|-----|---------------------------------|-----|----------|
| 3 | REV. PER LIMITS OF CAPPING PLAN | PMH | 12/12/14 |
| 2 | REV. PER COMMENTS | GJS | 5/9/14 |
| 1 | REV. FOR SUBMISSION | PMH | 3/3/14 |

12/12/14 DATE
WAYNE J. INGRAM
PROFESSIONAL ENGINEER
N.J. P.E. NO. 24GE048393

PROJECT: BOROUGH OF RINGWOOD
RECYCLING CENTER SITE PLAN
PETER'S MINE ROAD
BLOCK 601 LOT 14 TAX MAP SHEET 6.03
BOROUGH OF RINGWOOD
PASSAIC COUNTY NEW JERSEY

DETAILS

| | | | |
|-----------|-------------------|--------------|----|
| JOB NO.: | 13245C | DRAWING NO.: | 11 |
| SCALE: | NTS | | |
| DESIGNED: | PMH | | |
| CHECKED: | WJI | | |
| FILENAME: | 09_12_DETAILS.DWG | | |
| DATE: | 5/9/2014 | | 11 |